


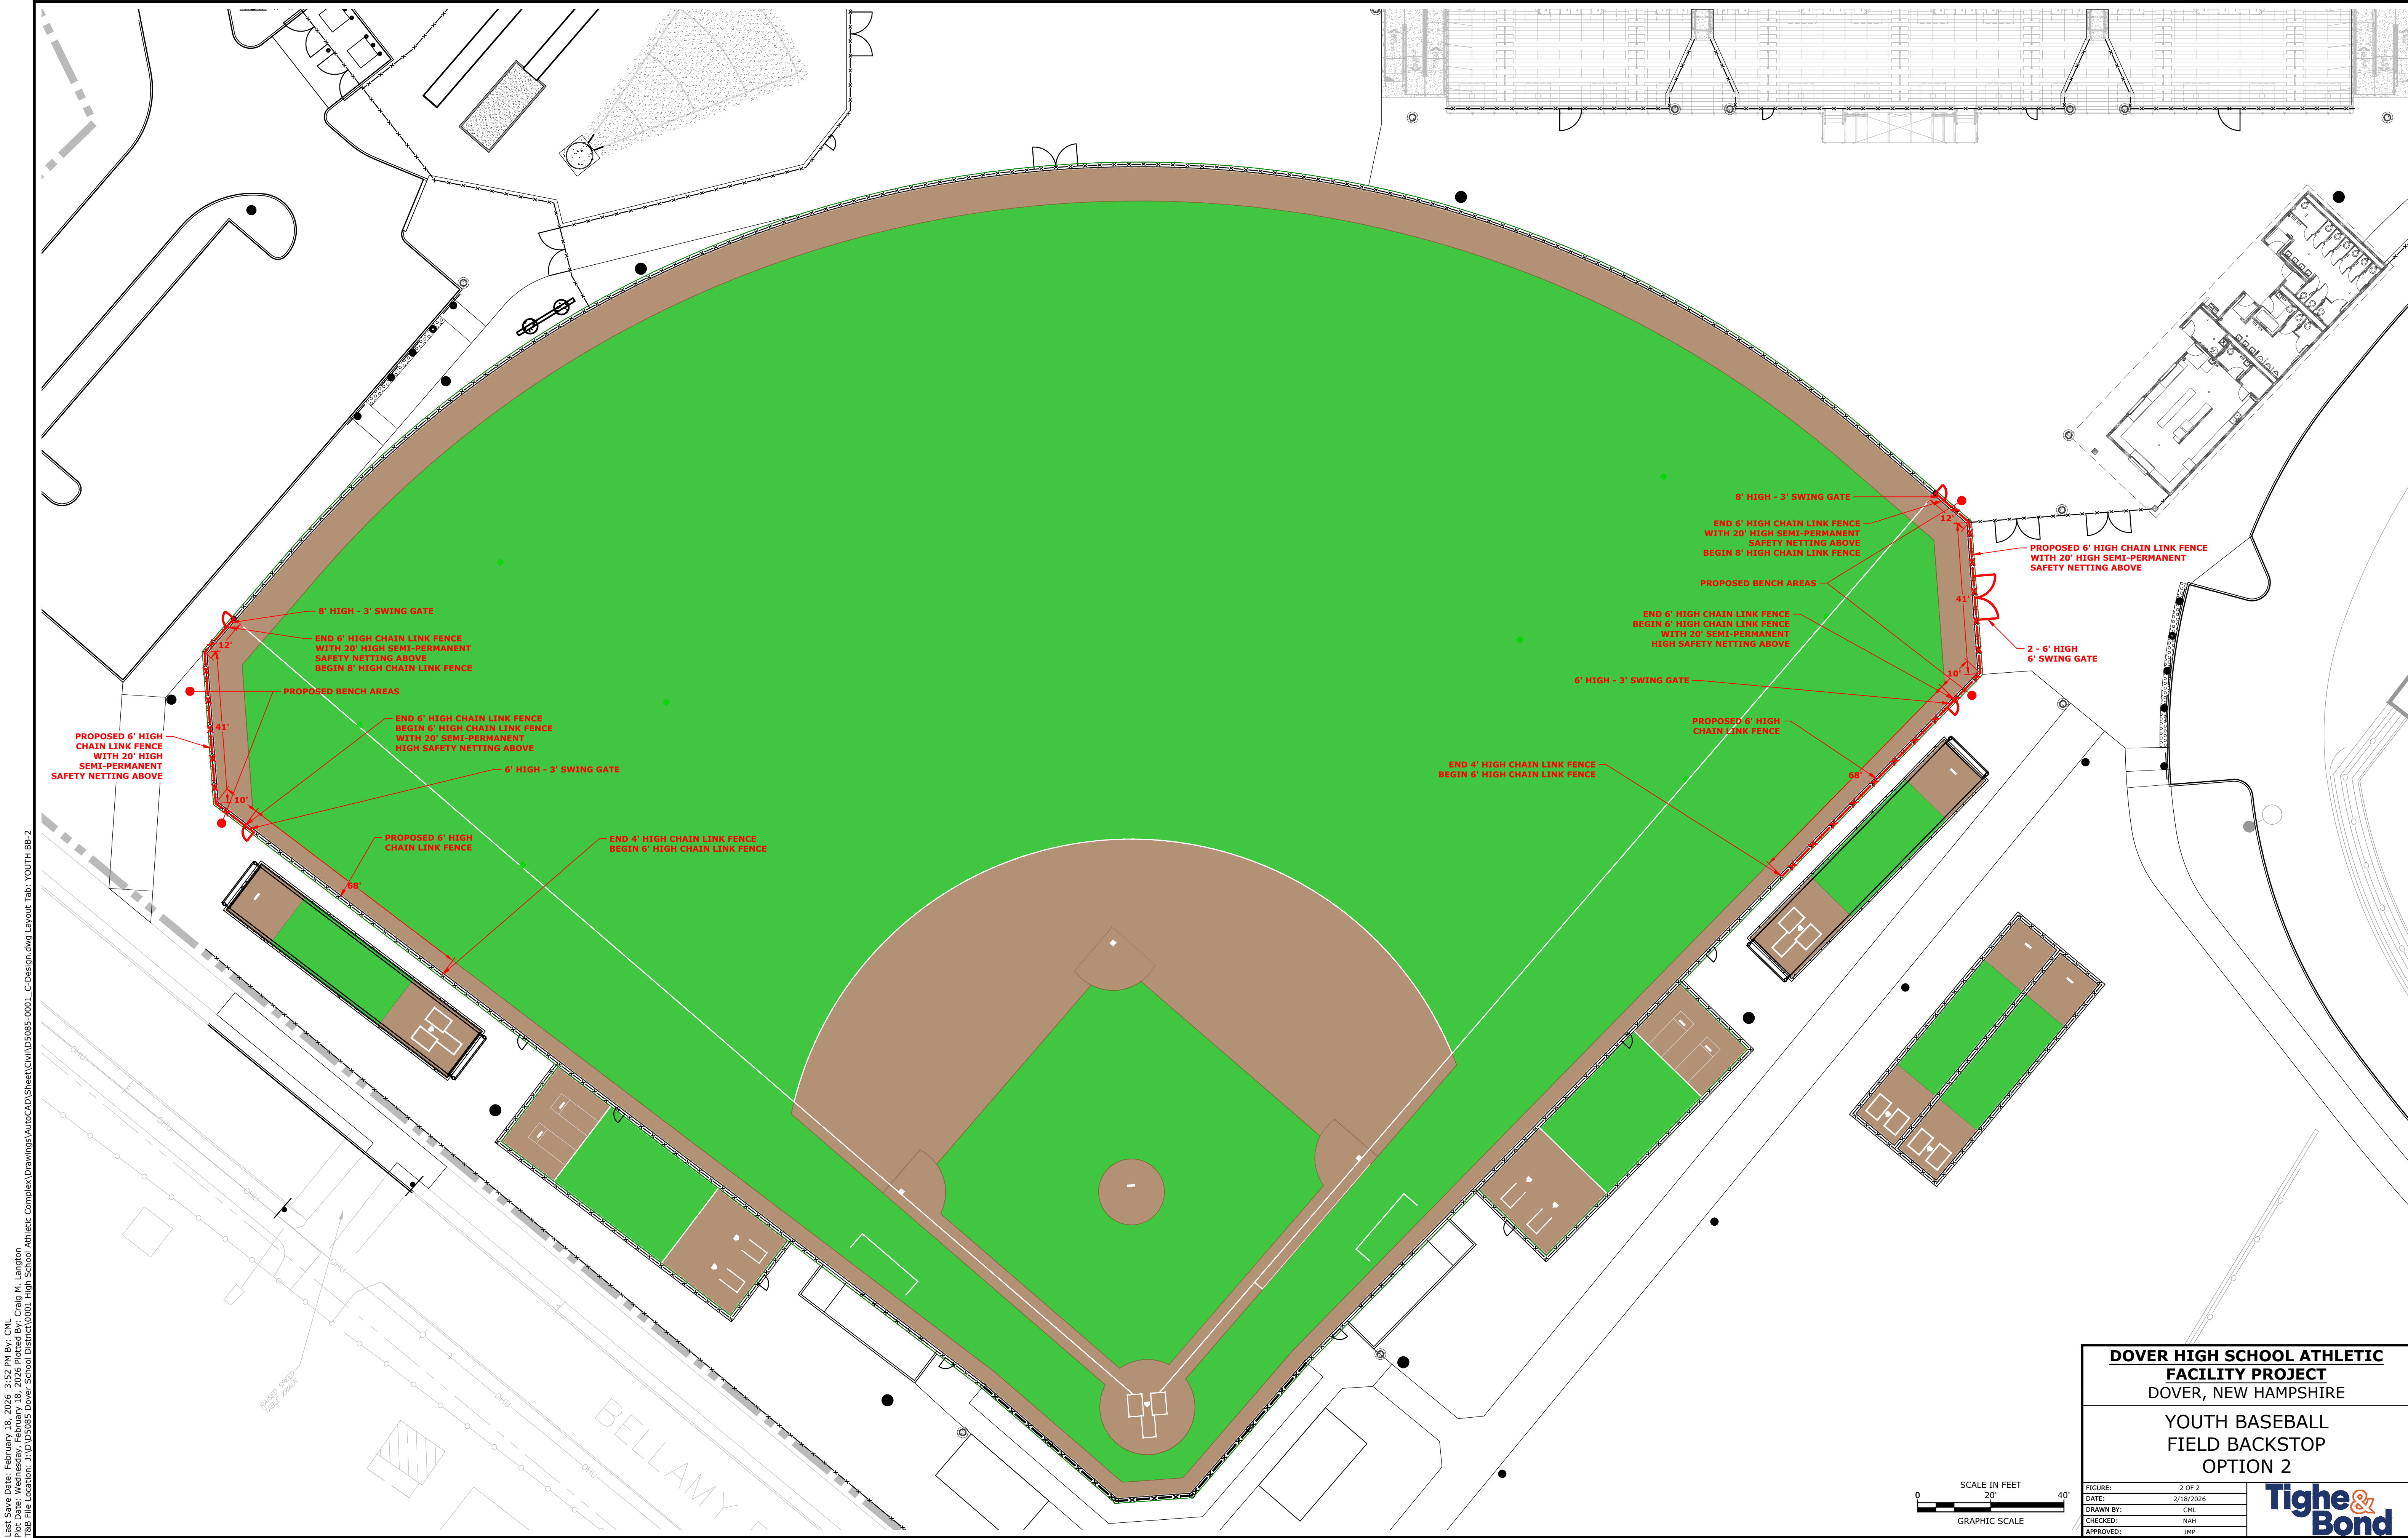

Last Save Date: February 18, 2026 3:52 PM By: CHL
Plot Date: Wednesday, February 18, 2026 Plotted By: Craig M. Langton
P&ID File Location: P:\D5085 Dover School District\001 High School Athletic Complex\Drawings\AutoCAD\Sheet\Civil\D5085-001 C-Design.dwg Layout Tab: YOUTH BB-2

DOVER HIGH SCHOOL ATHLETIC FACILITY PROJECT DOVER, NEW HAMPSHIRE	
YOUTH BASEBALL FIELD BACKSTOP OPTION 2	
FIGURE:	2 OF 2
DATE:	2/16/2026
DRAWN BY:	CHL
CHECKED:	NAH
APPROVED:	JMP

Tighe & Bond

